




1-1 Lighting - Groundplan
Scale: 1/4" = 1'-0"

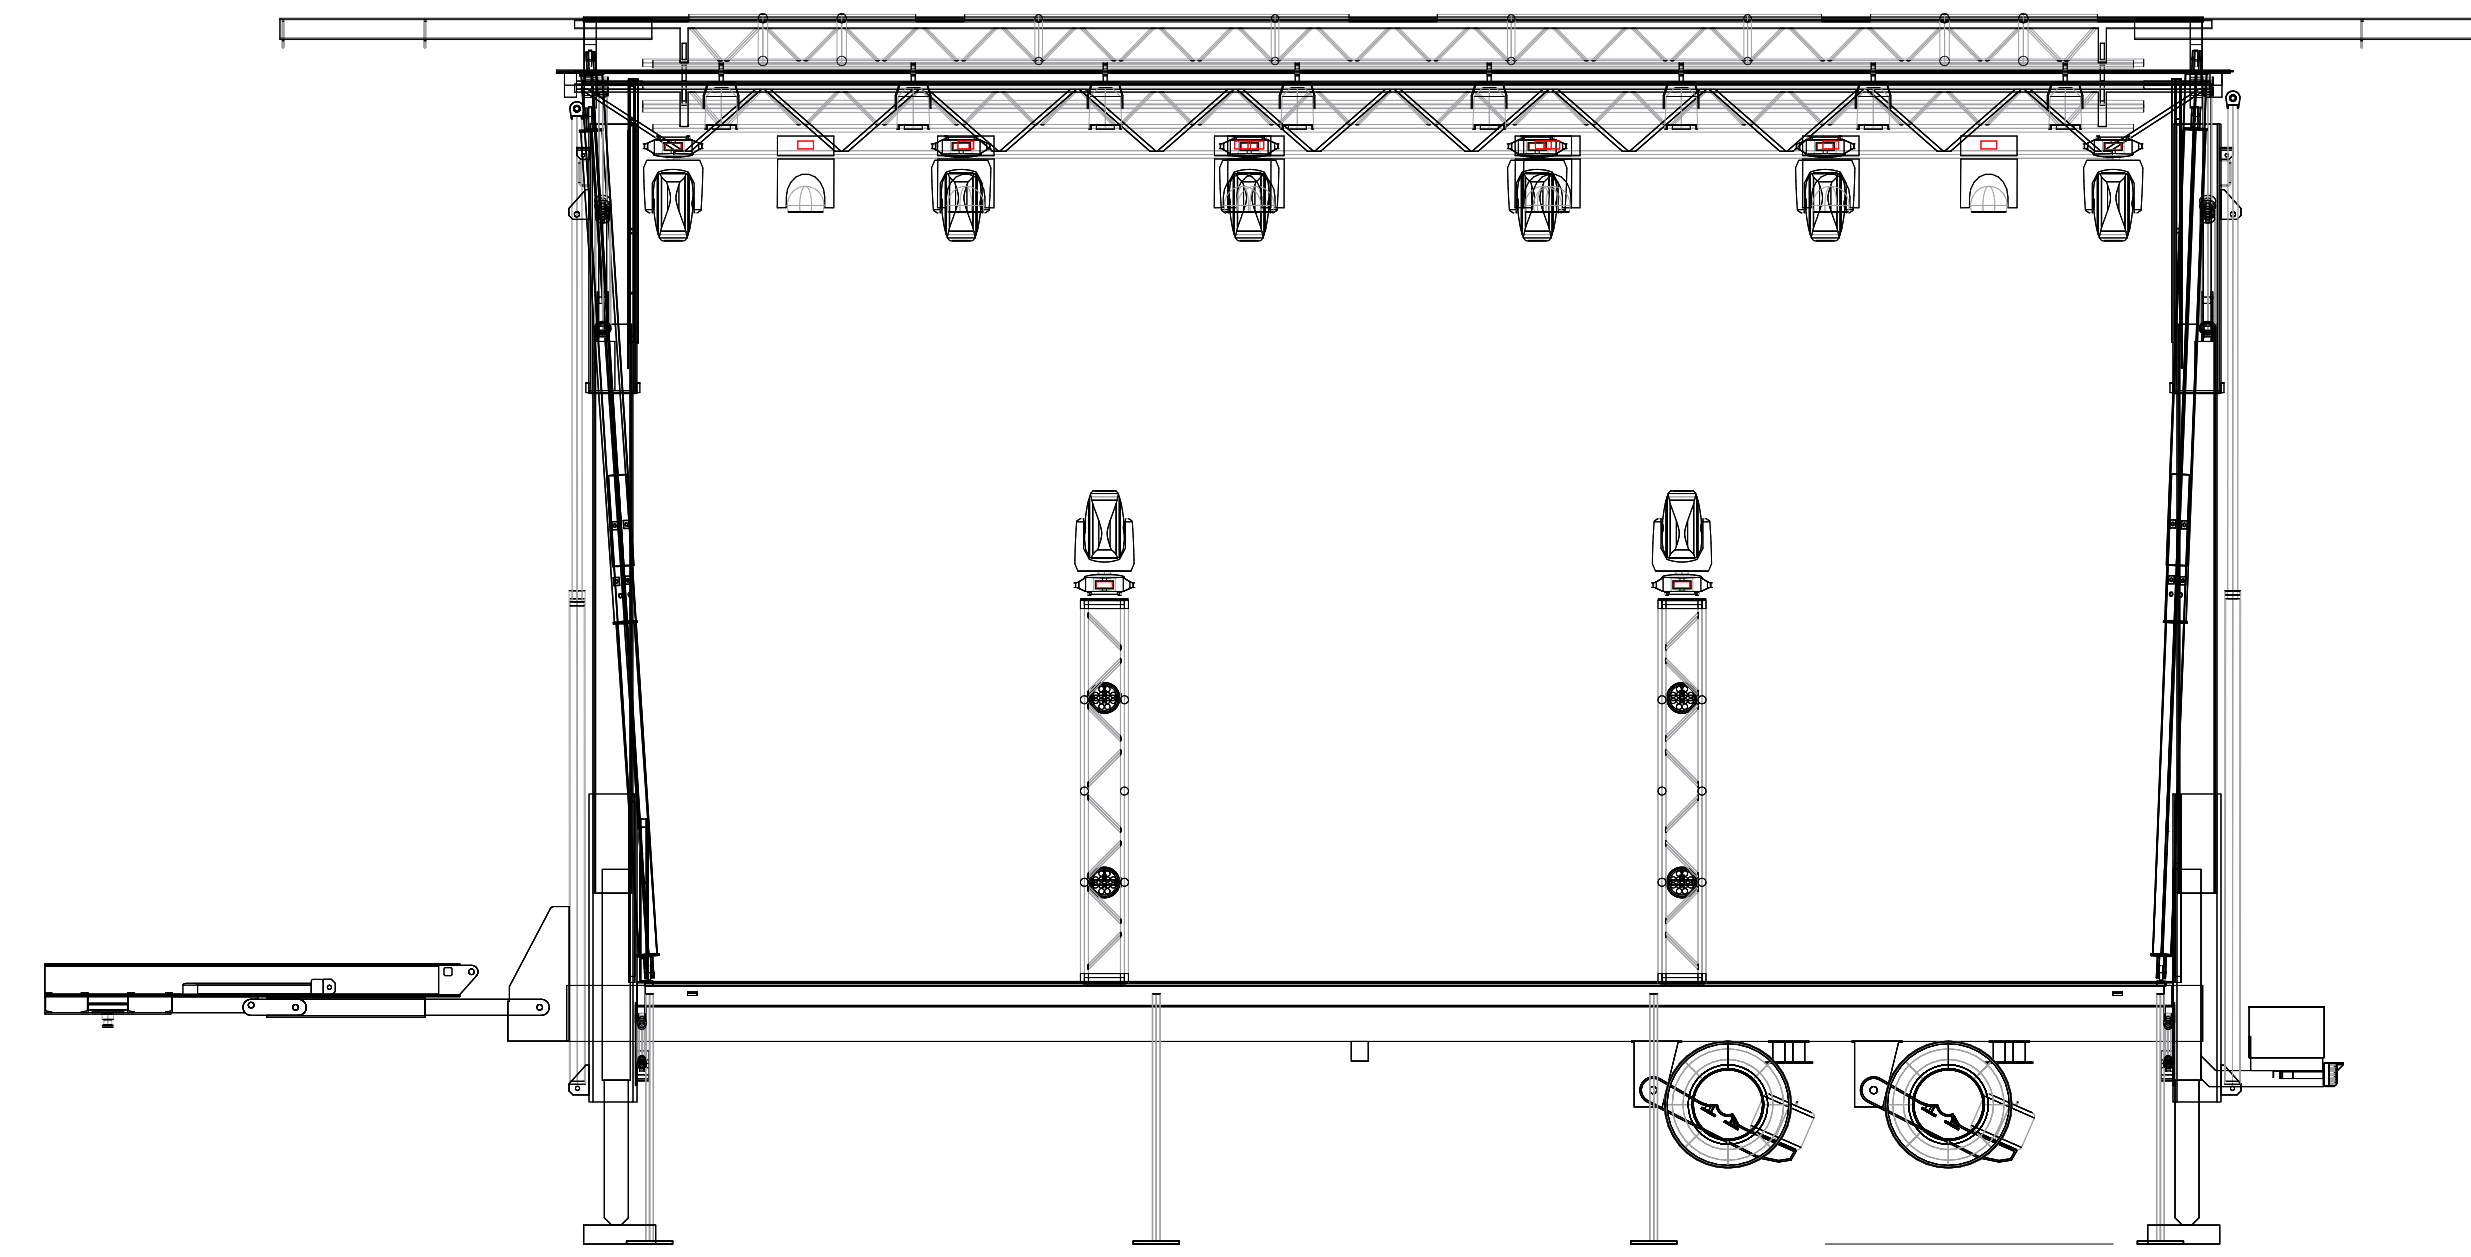


1-2 Lighting - Front Elevation
Scale: 1/4" = 1'-0"

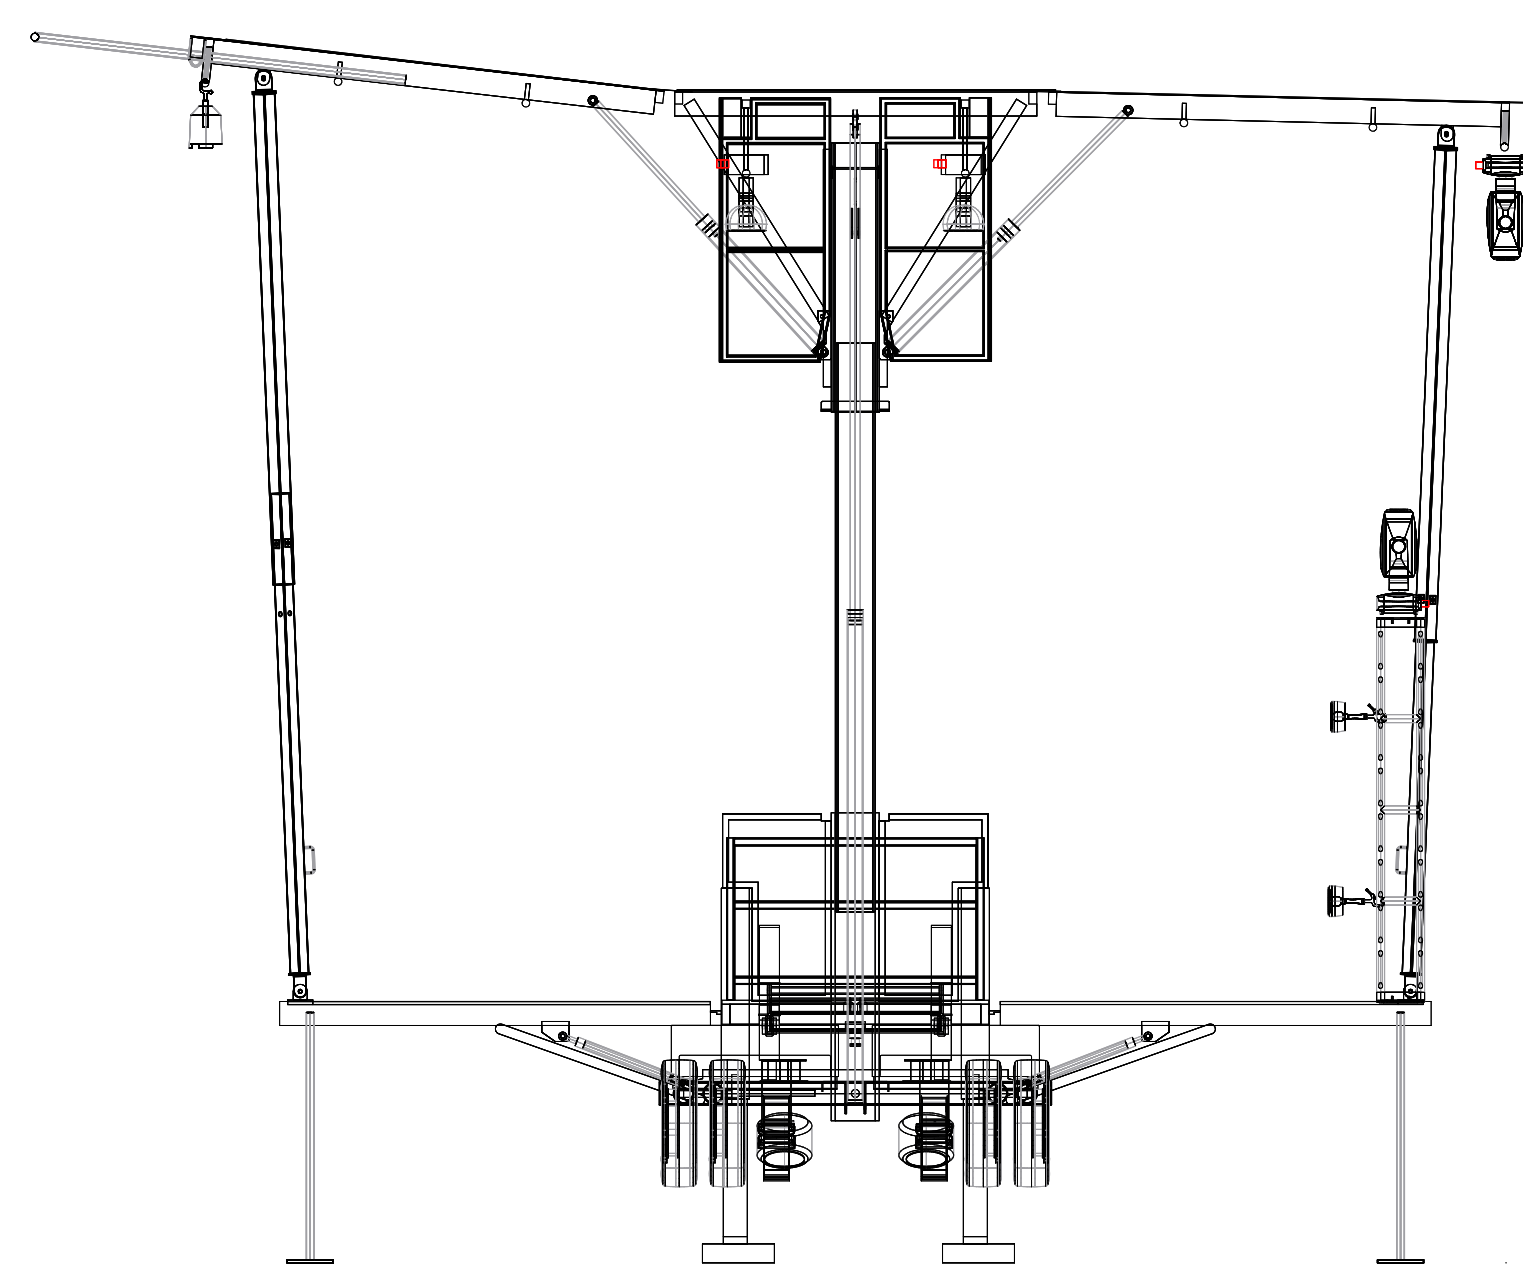


1-3 Lighting - Right Orthographic
Scale: 1/4" = 1'-0"

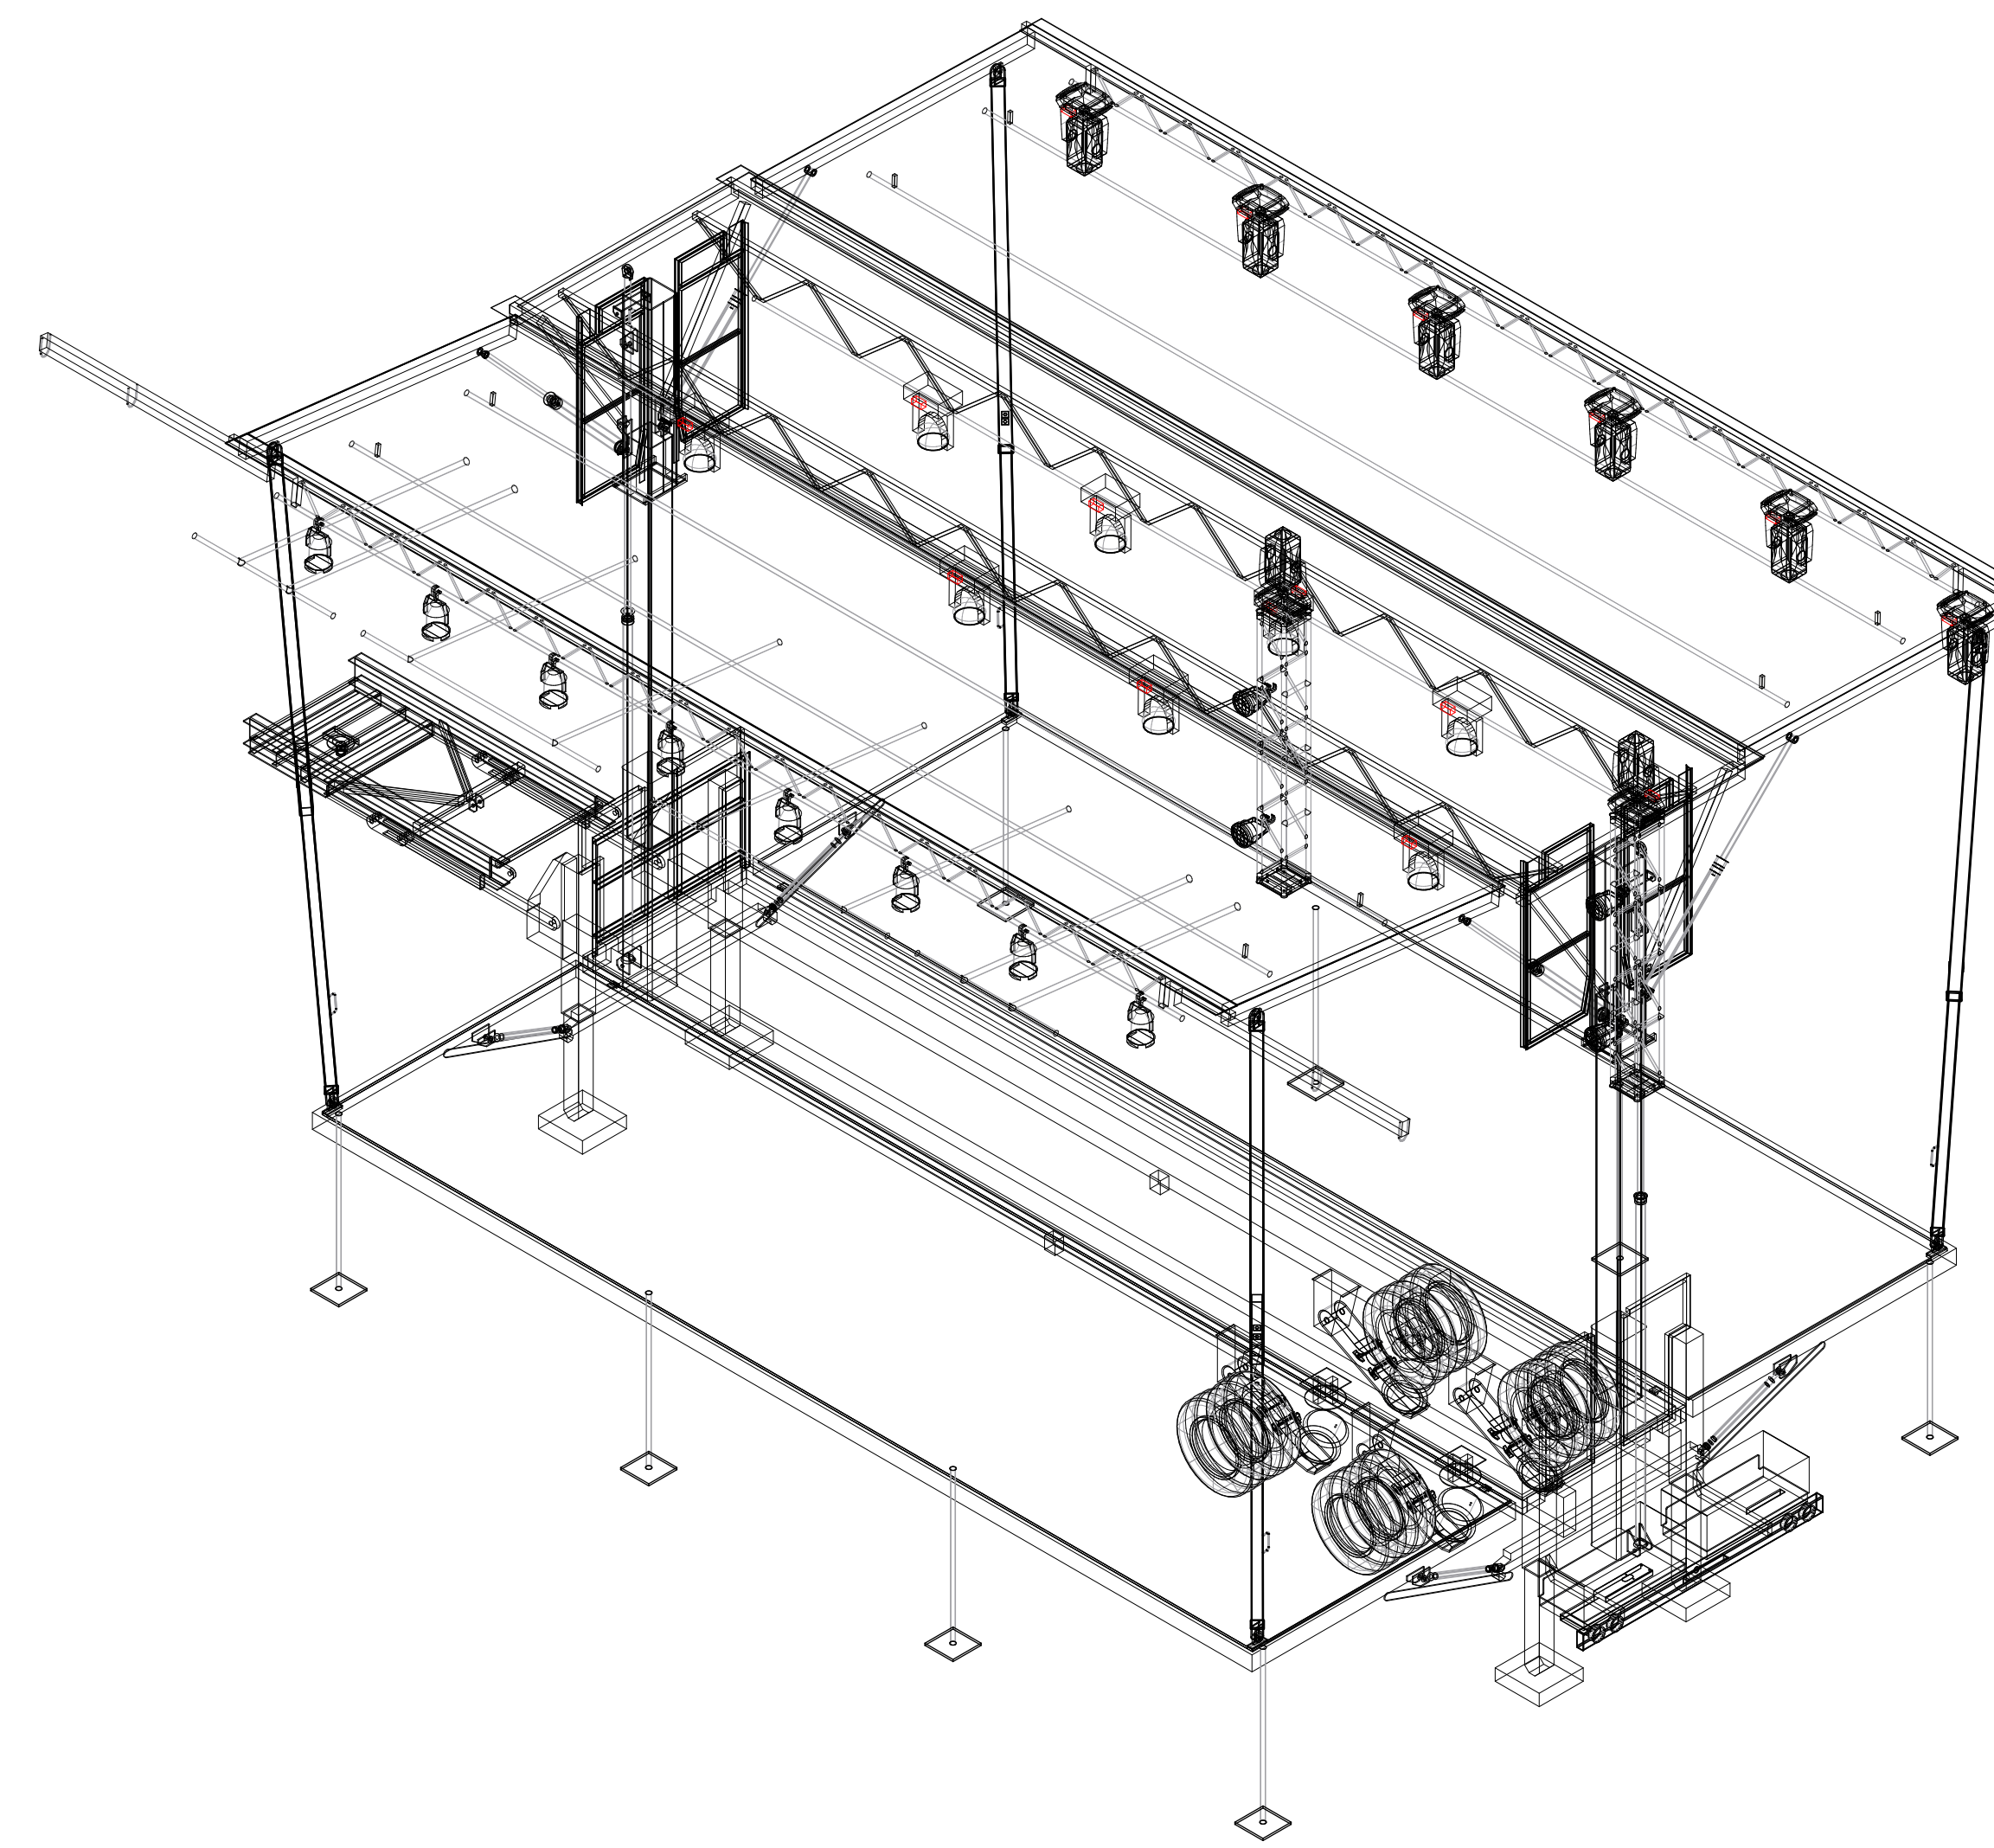

1-4 Lighting - Right Isometric
Scale: 1/4" = 1'-0"

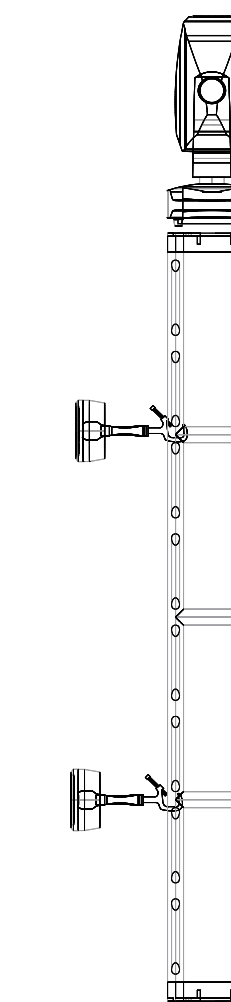

1-6 Truss Detail - Right Orthographic
Scale: 1/2" = 1'-0"

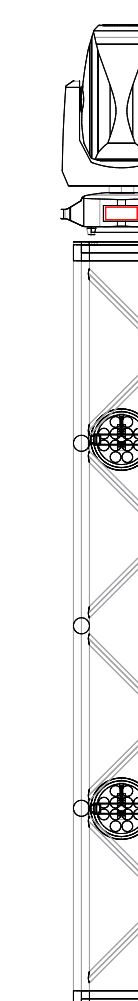

1-5 Truss Detail - Front
Scale: 1/2" = 1'-0"

INSTRUMENT SUMMARY

Light Instr Elaton ELAR 180 RGBWA Par (Sch)	8
Chauvet Rogue R2 Wash	8
Chauvet DJ SlimPAR Pro H USB	4
Elation Platinum HFX	8
Martin Atomic 3000 DMX	2

DISCLAIMER

THIS DRAWING REPRESENTS VISUAL CONCEPTS AND CONSTRUCTION SUGGESTIONS ONLY. THE DESIGNER IS NOT QUALIFIED TO DETERMINE THE STRUCTURAL APPROPRIATENESS OF THIS DESIGN AND WILL NOT ASSUME RESPONSIBILITY FOR IMPROPER ENGINEERING, CONSTRUCTION, OR HANDLING. ALL MATERIALS, FINISHES, AND CONSTRUCTION MUST COMPLY WITH FIRE AND SAFETY CODES AS APPLICABLE.

No.	Date	By	Revision Notes
A	8/25/2021		Initial concept plot

No.	Date	Issue Notes

Ayre Productions	
4255 N Knox Ave	
Chicago IL, 60641	


AYRE PRODUCTIONS	
Ayre Productions	
4255 N Knox Ave	
Chicago IL, 60641	

JACK WEIMER	
jack@ayreproductions.com	
614-580-4268	

Project Title	
Prairie Fest 2021	

Sheet Title	
Lighting - Composite	

Project Manager	Project ID
Joey Wagner	PF2021
Drawn By	Date
Jack Weimer	See Annotation
Reviewed By	Sheet No.
	1
Date	of
9/1/2021	5
Client Name	
Prairie Fest.vwx	

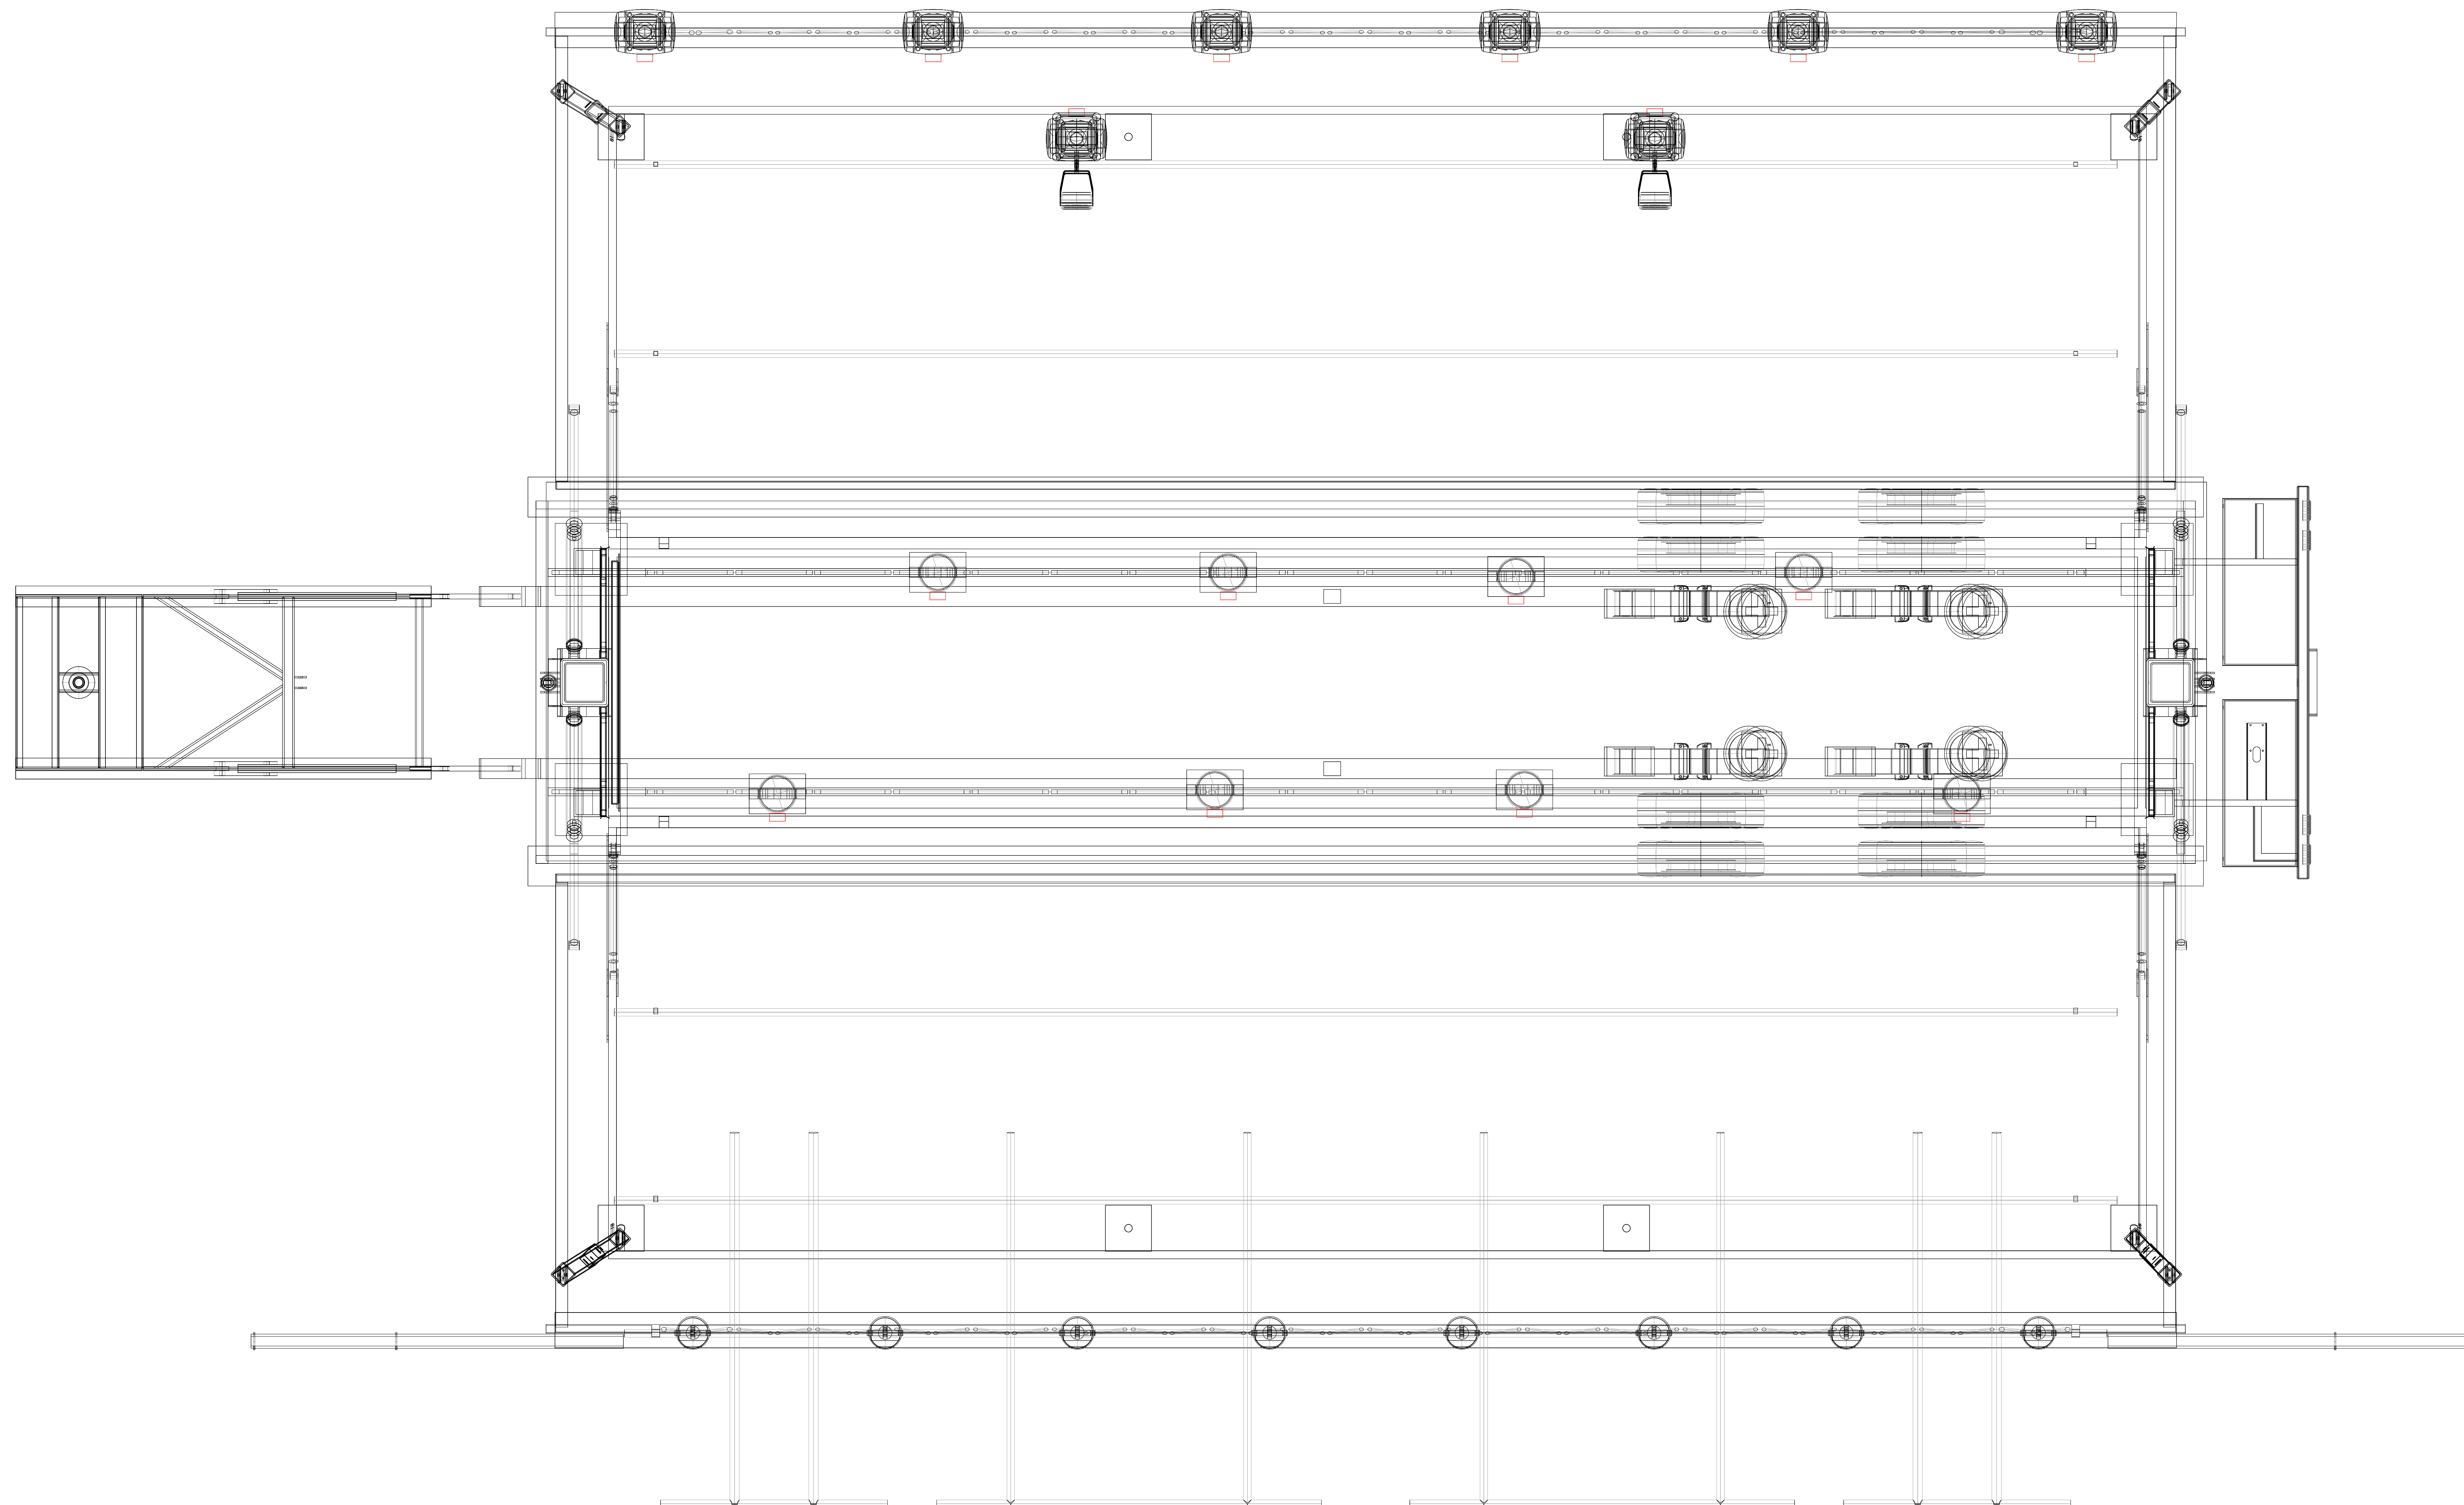


INSTRUMENT SUMMARY

Light Instr Elation ELAR 180 RGBWA Par (5ch)	8
Chauvet Rogue R2 Wash	8
Chauvet DJ SlimPAR Pro H USB	4
Elation Platinum HFX	8
Martin Atomic 3000 DMX	2

DISCLAIMER

THIS DRAWING REPRESENTS VISUAL CONCEPTS AND CONSTRUCTION SUGGESTIONS ONLY. THE DESIGNER IS NOT QUALIFIED TO DETERMINE THE STRUCTURAL APPROPRIATENESS OF THIS DESIGN AND WILL NOT ASSUME RESPONSIBILITY FOR IMPROPER ENGINEERING, CONSTRUCTION, OR HANDLING. ALL MATERIALS, FINISHES, AND CONSTRUCTION MUST COMPLY WITH FIRE AND SAFETY CODES AS APPLICABLE.

No.	Date	By	Revision Notes
A	8/25/2021		Initial concept plot

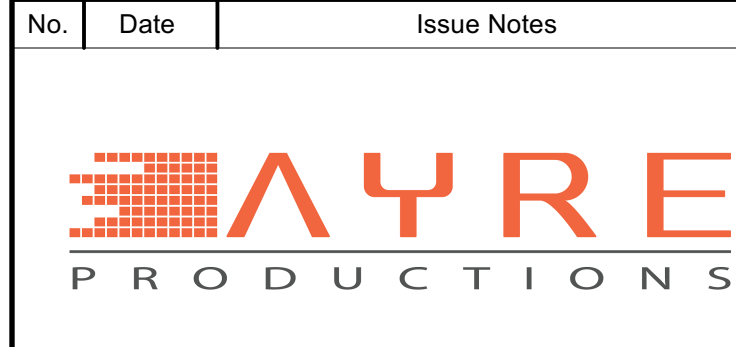

Ayre Productions
 4255 N Knox Ave
 Chicago IL, 60641


JACK WEIMER
 jack@ayreproductions.com
 614-580-4268

Prairie Fest 2021


Lighting - Groundplan

Project Manager Joey Wagner	Project ID PF2021
Drawn By Jack Weimer	Date See Annotation
Reviewed By	Sheet No. 2
Date 9/1/2021	of 5
CDR File Name Prairie Fest.vwx	

2-1 Lighting - Groundplan
 Scale: 3/4" = 1'-0"

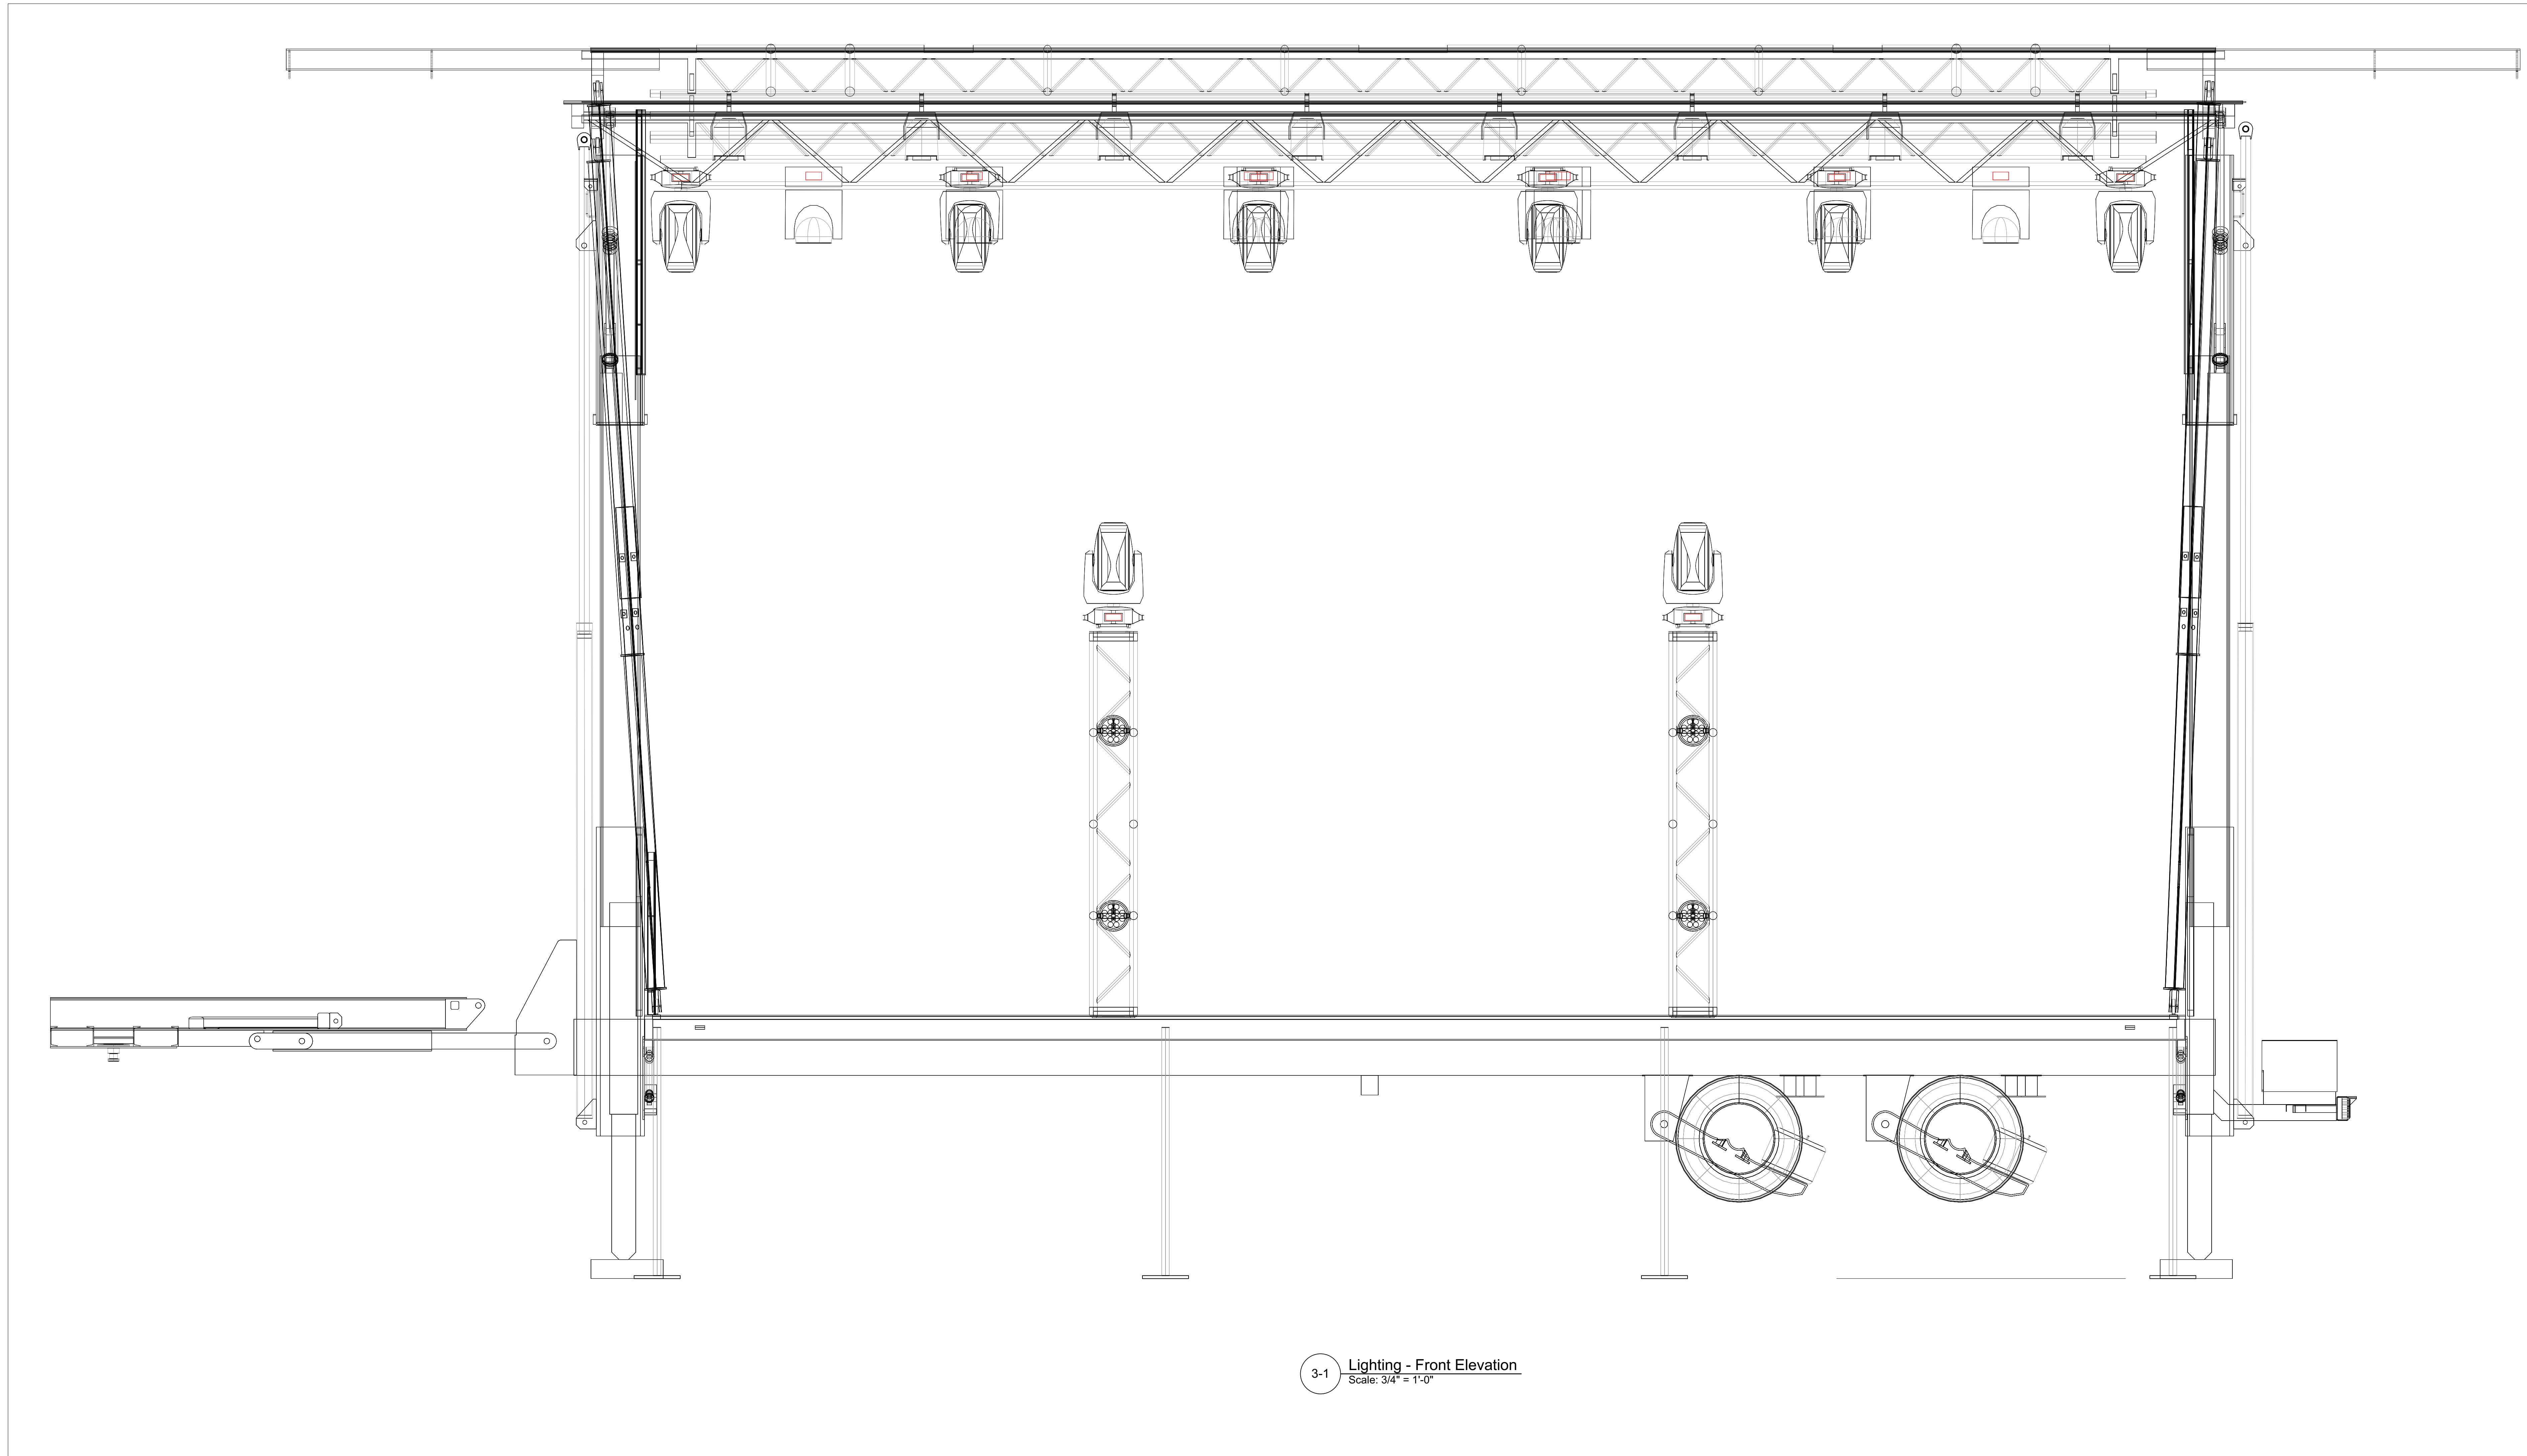

3-1 Lighting - Front Elevation
Scale: 3/4" = 1'-0"

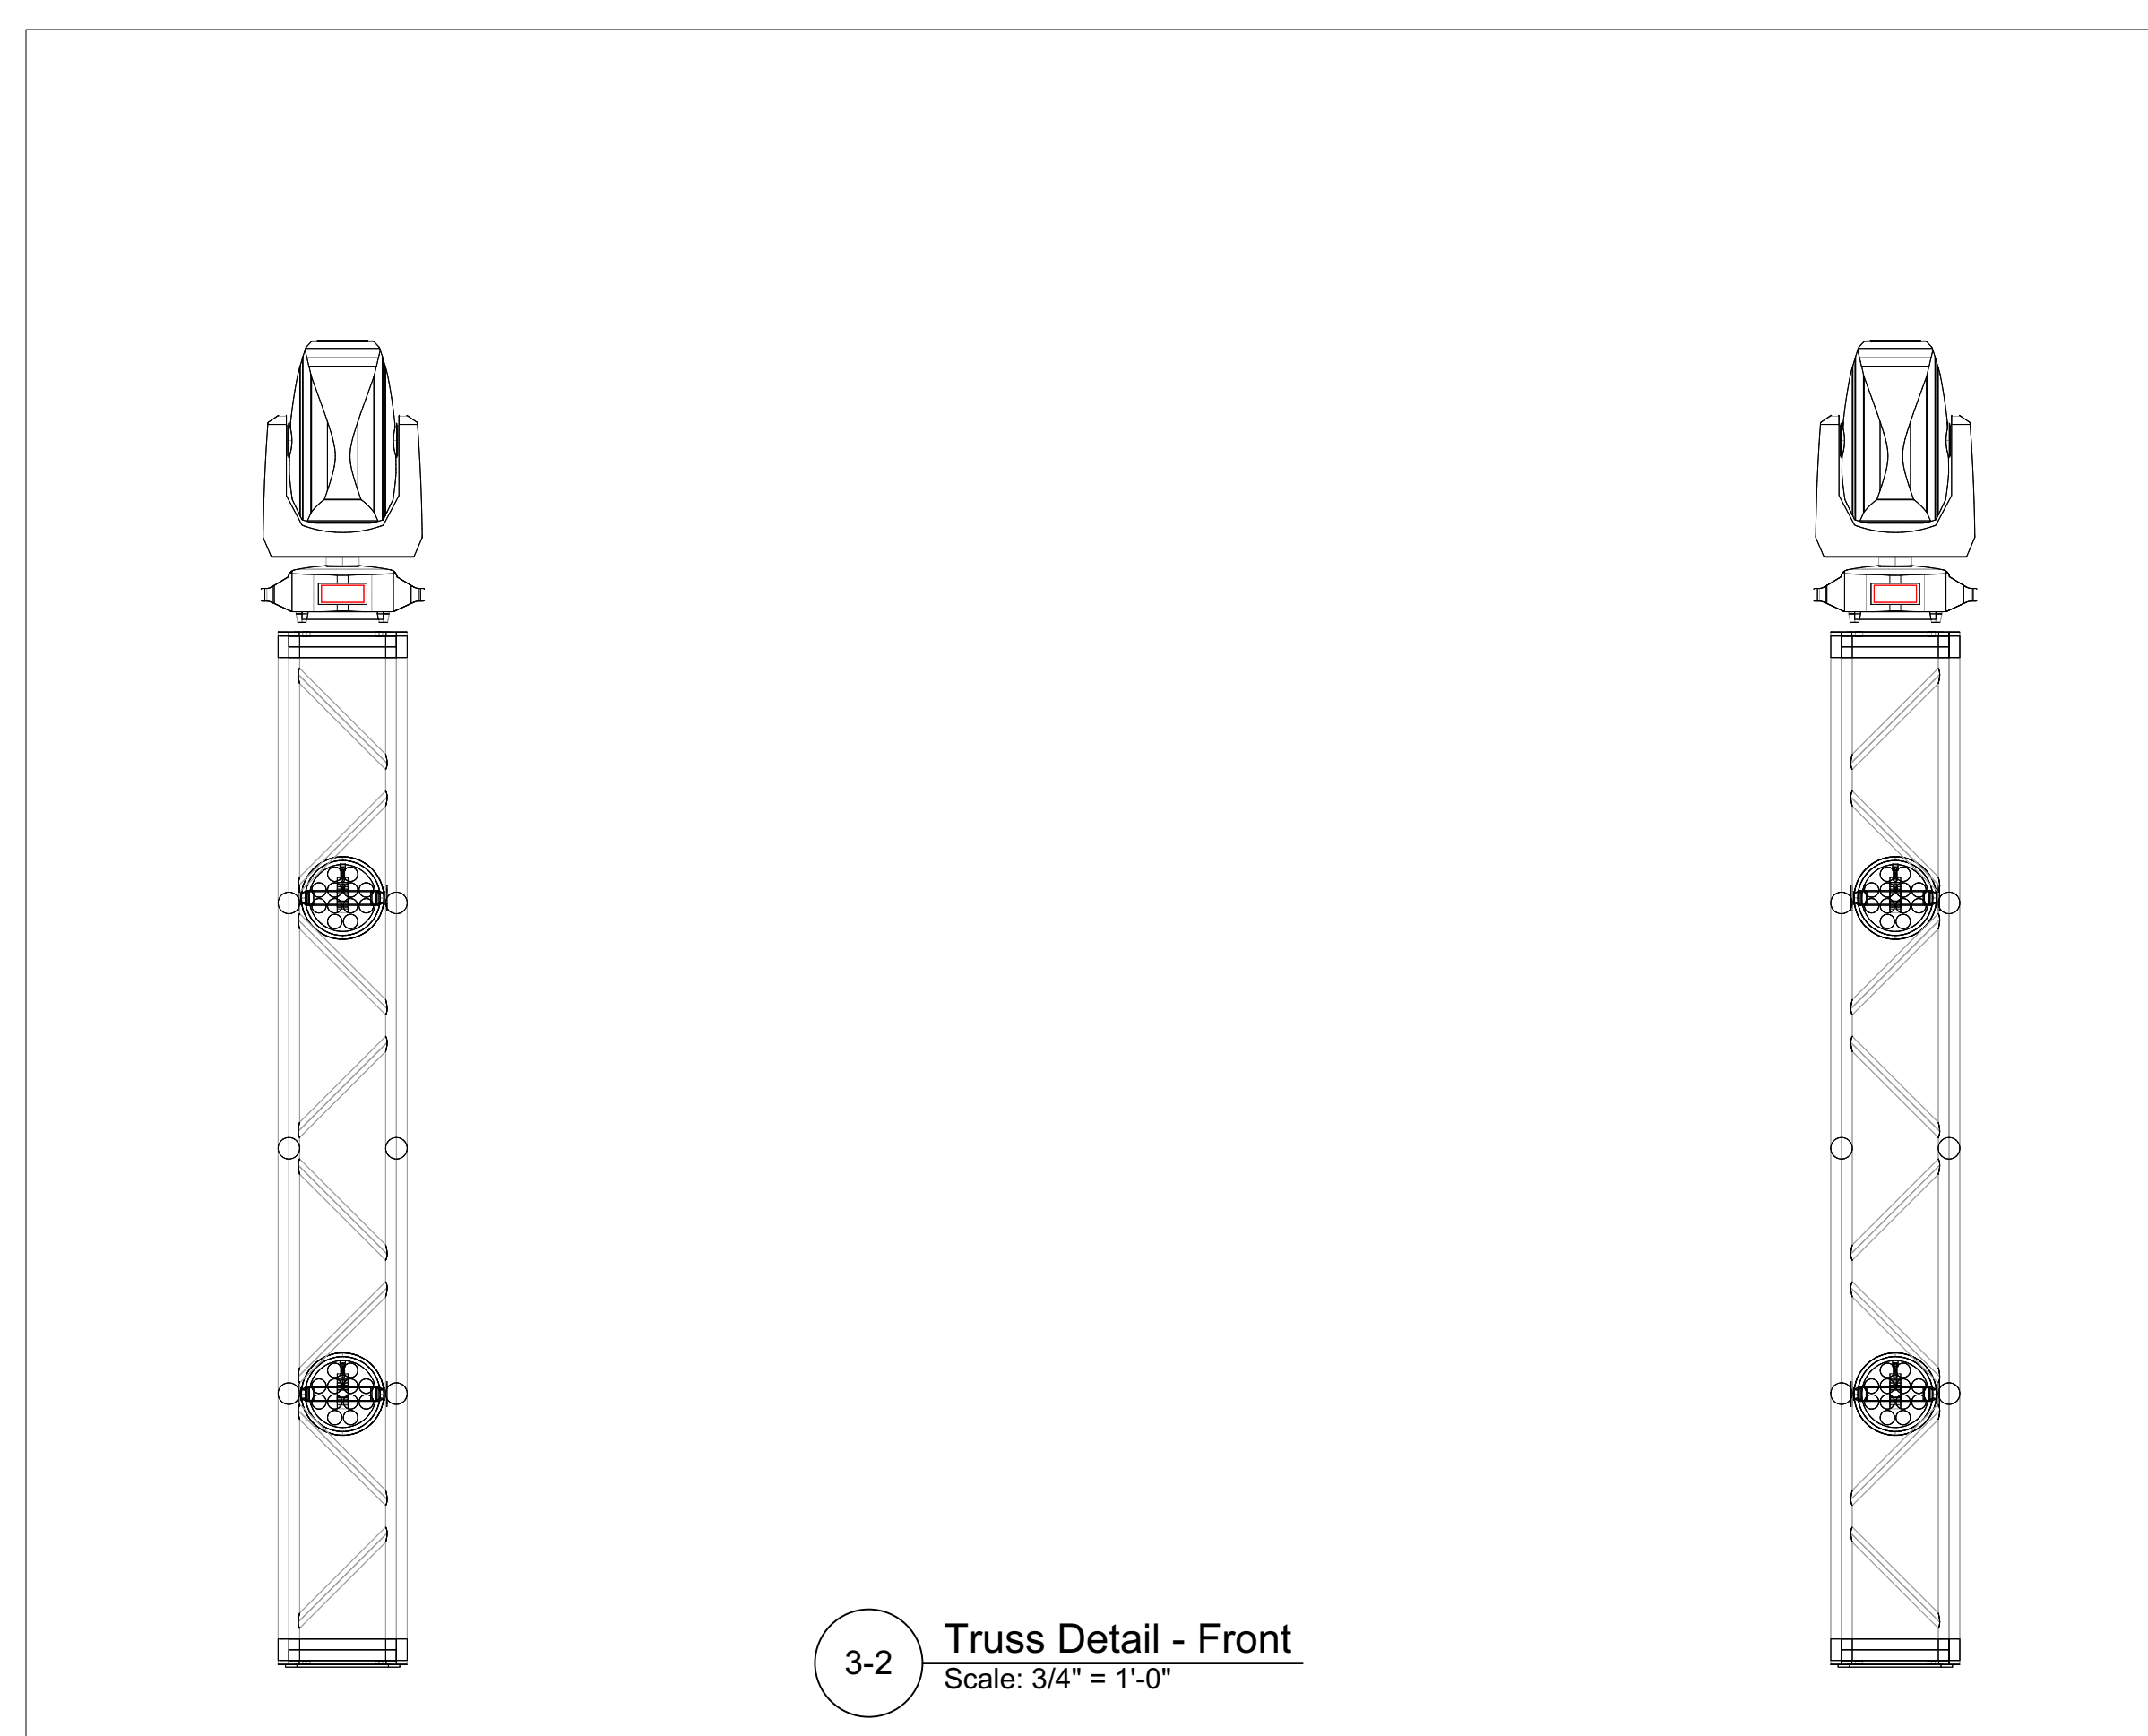

3-2 Truss Detail - Front
Scale: 3/4" = 1'-0"

INSTRUMENT SUMMARY

Light Instr Elaton	8
ELAR 180 RGBWA	8
Par (5ch)	8
Chauvet Rogue R2	8
Wash	8
Chauvet DJ	4
SlimPAR Pro H	4
USB	4
Elaton Platinum	8
HFX	8
Martin Atomic 3000	2
DMX	2

DISCLAIMER

THIS DRAWING REPRESENTS VISUAL CONCEPTS AND CONSTRUCTION SUGGESTIONS ONLY. THE DESIGNER IS NOT QUALIFIED TO DETERMINE THE STRUCTURAL APPROPRIATENESS OF THIS DESIGN AND WILL NOT ASSUME RESPONSIBILITY FOR IMPROPER ENGINEERING, CONSTRUCTION, OR HANDLING. ALL MATERIALS, FINISHES, AND CONSTRUCTION MUST COMPLY WITH FIRE AND SAFETY CODES AS APPLICABLE.

No.	Date	By	Revision Notes
A	8/25/2021		Initial concept plot

AYRE PRODUCTIONS


Ayre Productions
4255 N Knox Ave
Chicago IL, 60641

OWNER: JACK WEIMER
jack@ayreproductions.com
614-580-4268


PROJECT TITLE: Prairie Fest 2021

DRAWING TITLE: Lighting - Front Elevation

Project Manager	Joey Wagner	Project ID	PF2021
Drawn By	Jack Weimer	Date	See Annotation
Reviewed By		Sheet No.	3
Date	9/1/2021		
CDR File Name	Prairie Fest.vwx		5

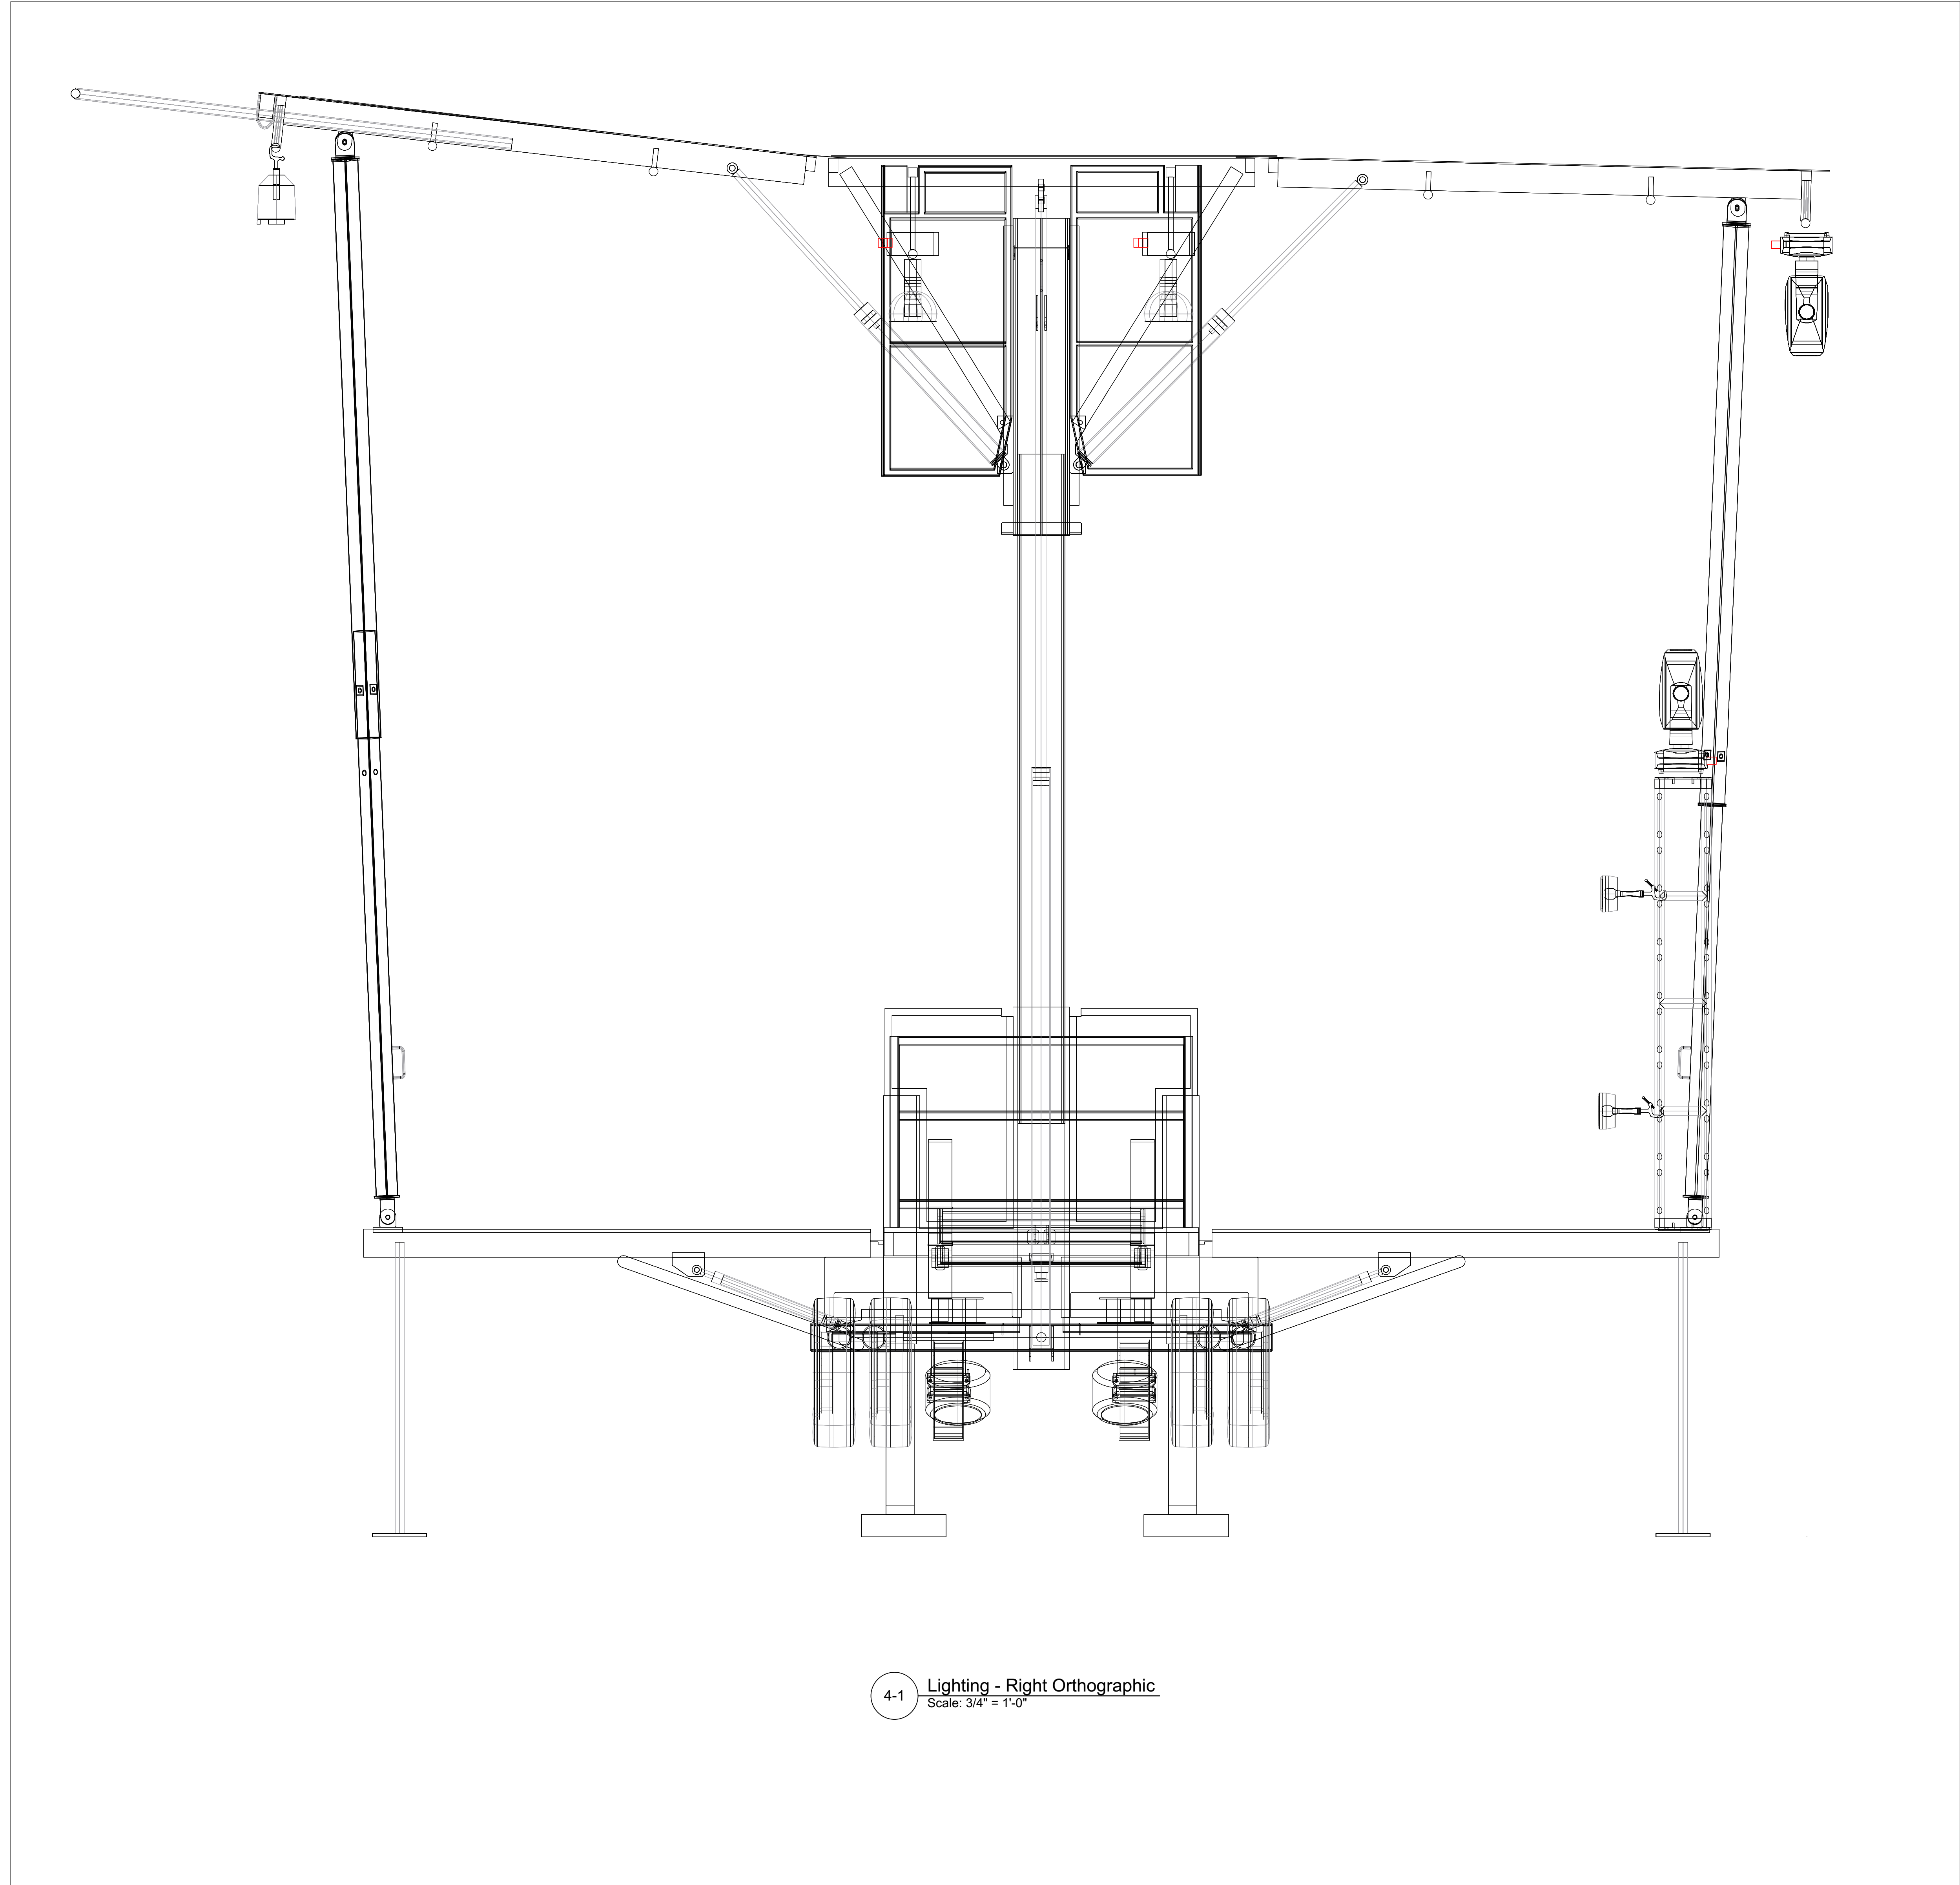

4-1 Lighting - Right Orthographic
Scale: 3/4" = 1'-0"

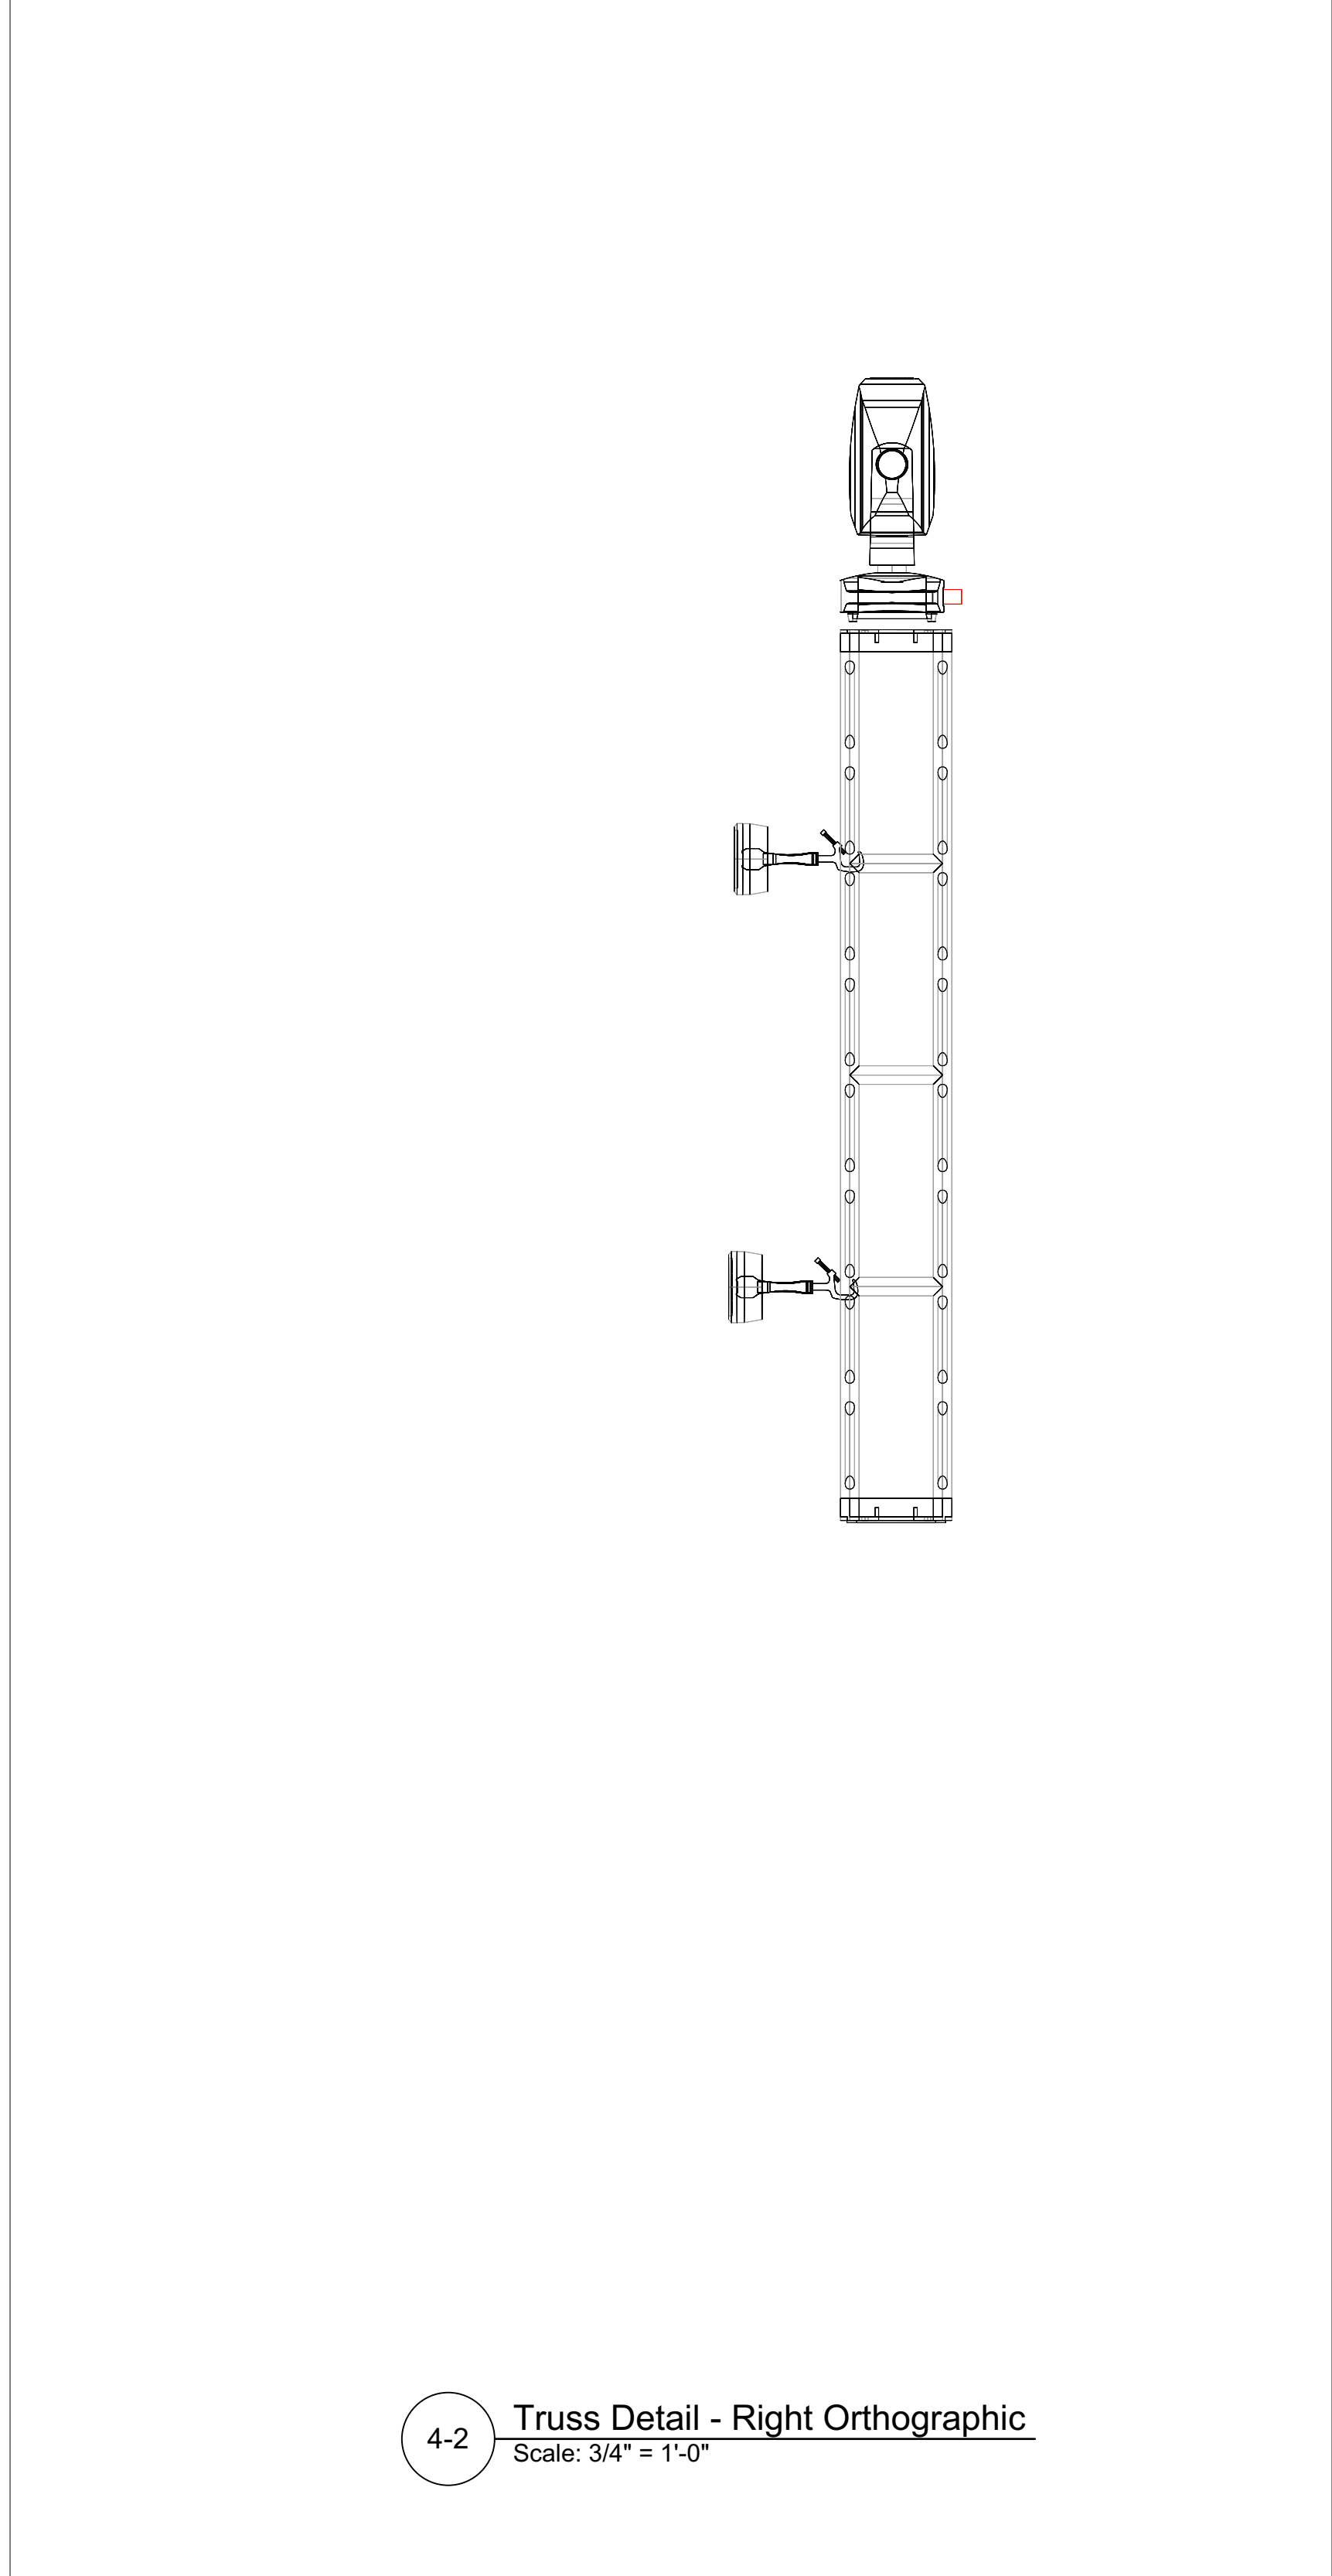

4-2 Truss Detail - Right Orthographic
Scale: 3/4" = 1'-0"

INSTRUMENT SUMMARY

Light Instr Elaton ELAR 180 RGBWA Par (5ch)	8
Chauvet Rogue R2 Wash	8
Chauvet DJ SlimPAR Pro H USB	4
Elation Platinum HFX	8
Martin Atomic 3000 DMX	2

DISCLAIMER

THIS DRAWING REPRESENTS VISUAL CONCEPTS AND CONSTRUCTION SUGGESTIONS ONLY. THE DESIGNER IS NOT QUALIFIED TO DETERMINE THE STRUCTURAL APPROPRIATENESS OF THIS DESIGN AND WILL NOT ASSUME RESPONSIBILITY FOR IMPROPER ENGINEERING, CONSTRUCTION, OR HANDLING. ALL MATERIALS, FINISHES, AND CONSTRUCTION MUST COMPLY WITH FIRE AND SAFETY CODES AS APPLICABLE.

No.	Date	By	Revision Notes
A	8/25/2021		Initial concept plot




Ayre Productions
4255 N Knox Ave
Chicago IL, 60641

Author: JACK WEIMER
jack@ayreproductions.com
614-580-4268

Project Title: Prairie Fest 2021

Sheet Title: Lighting - Right Orthographic

Project Manager: Joey Wagner	Project ID: PF2021
Drawn By: Jack Weimer	Date: See Annotation
Reviewed By:	Sheet No. 4
Date: 9/1/2021	of 5
CDR File Name: Prairie Fest.vwx	

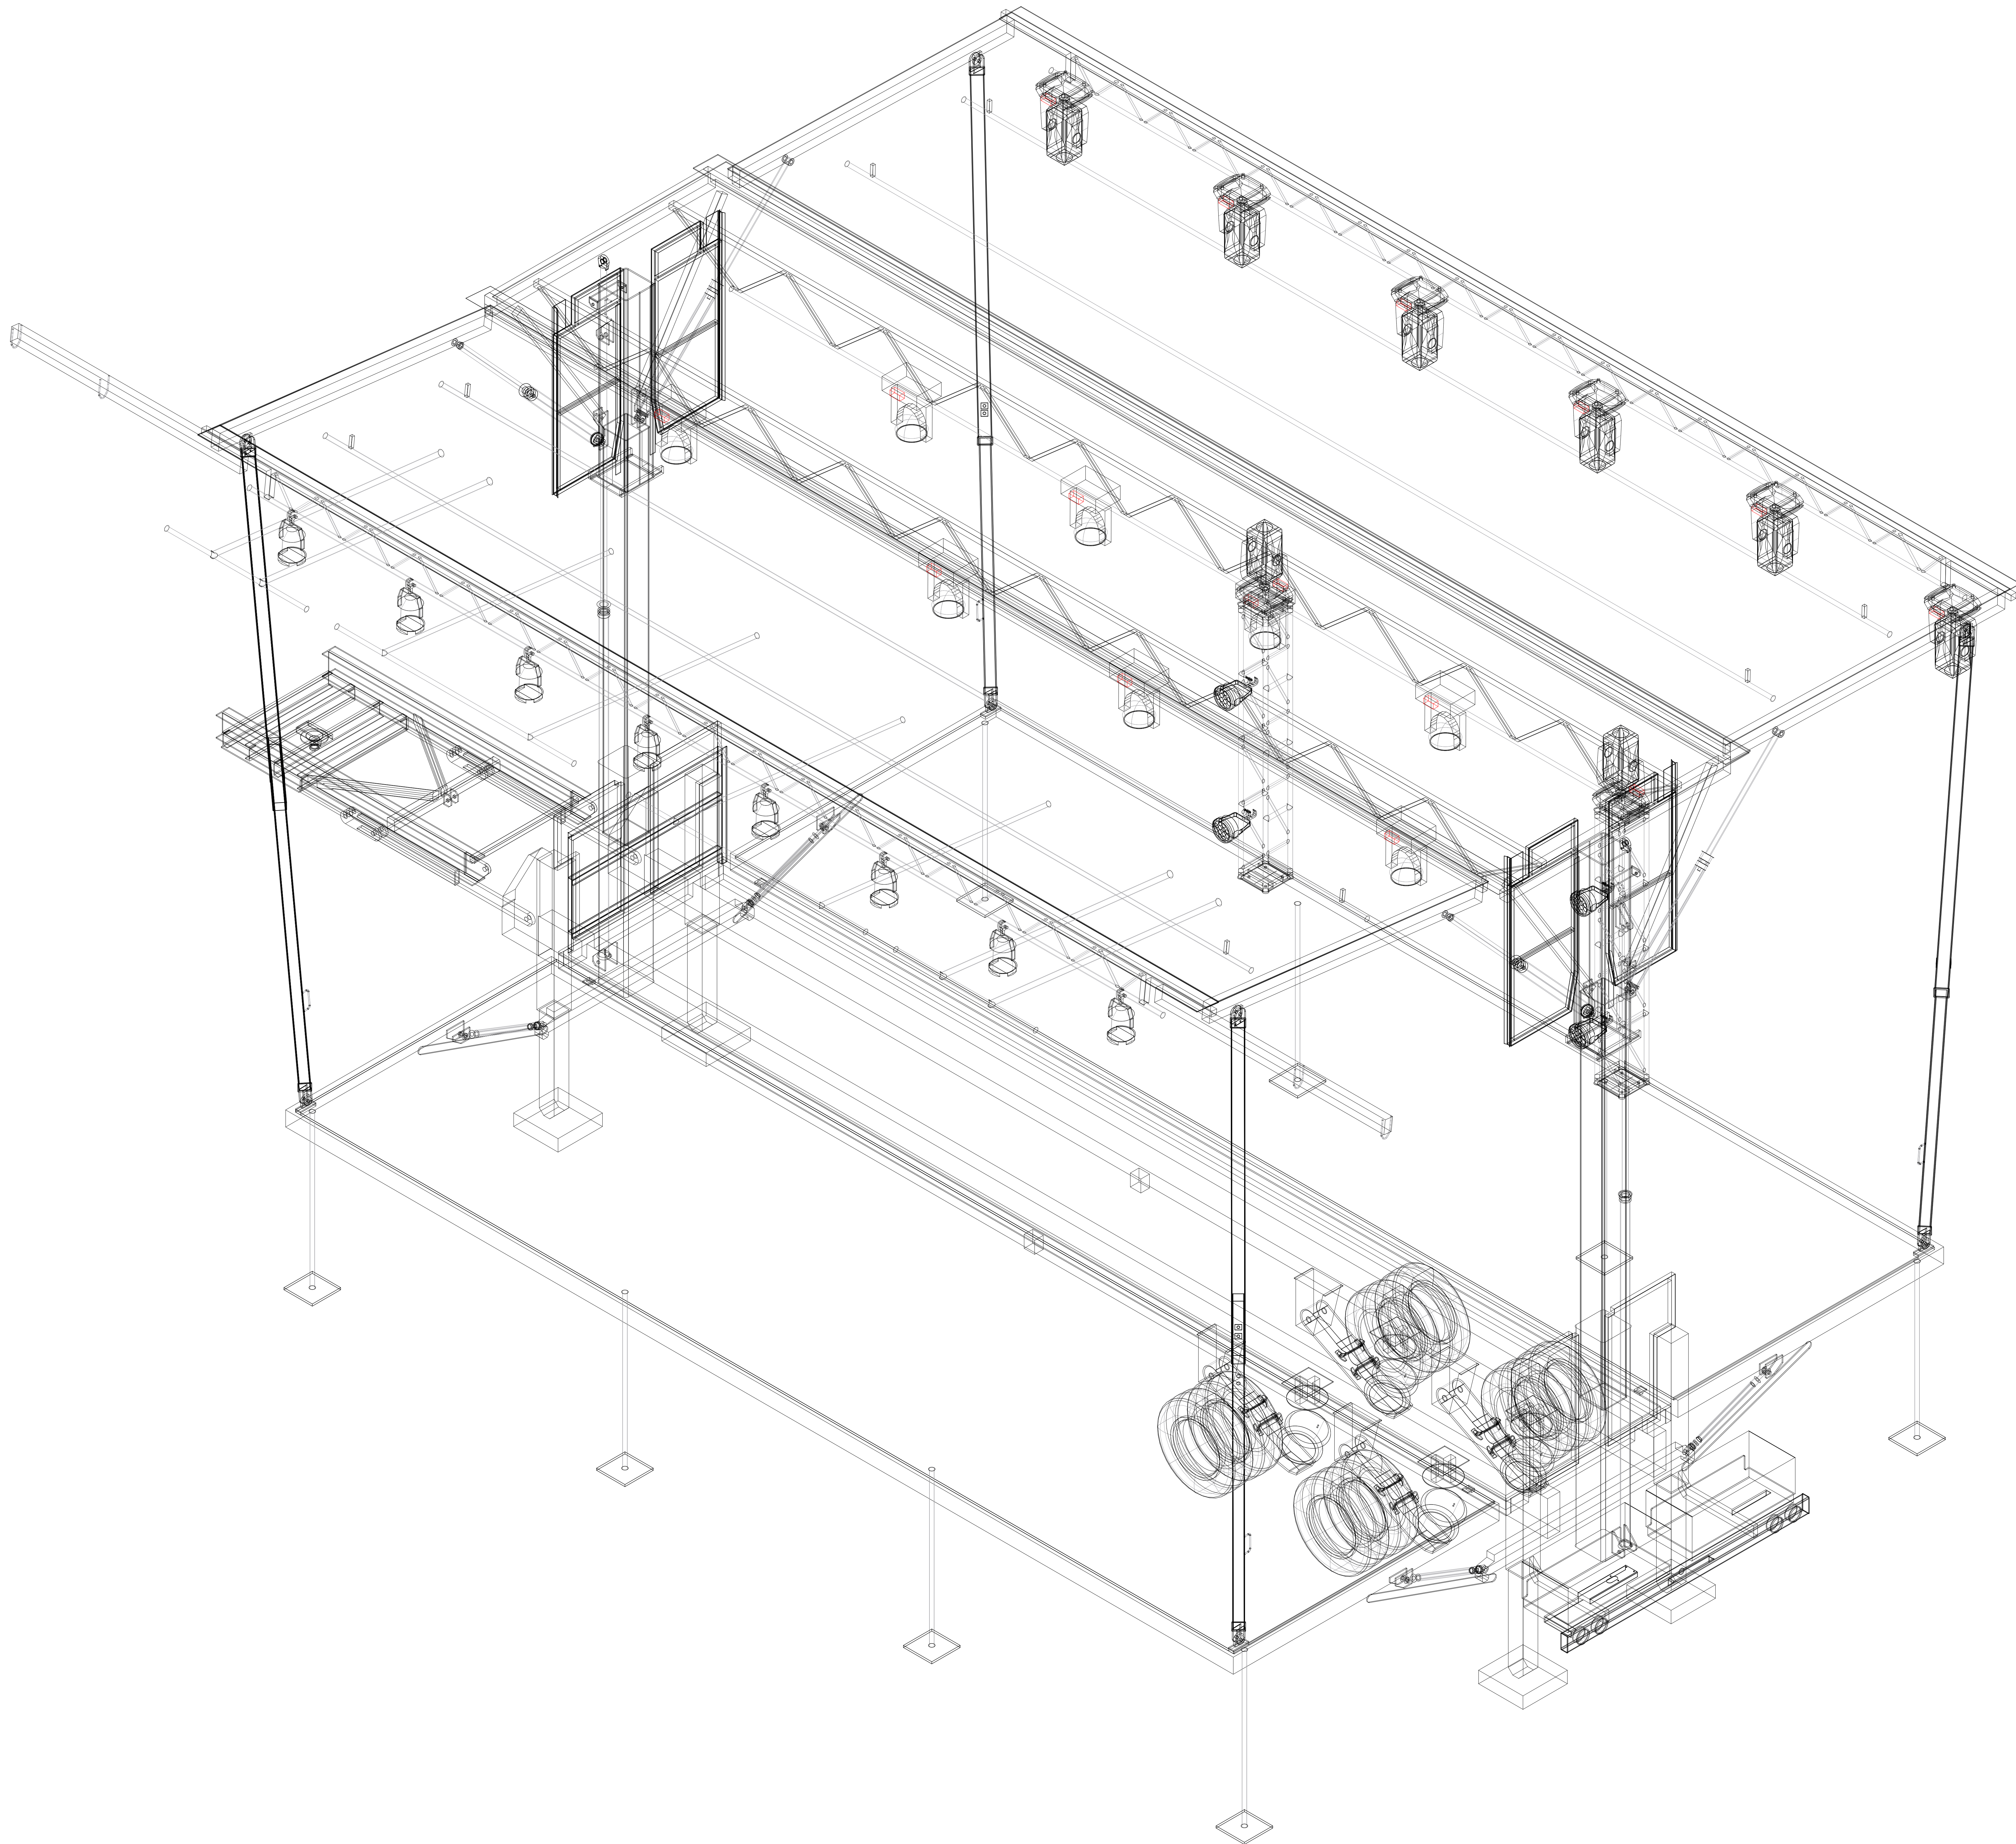

INSTRUMENT SUMMARY

Light Instr Elaton ELAR 180 RGBWA Par (5ch)	8
Chauvet Rogue R2 Wash	8
Chauvet DJ SlimPAR Pro H USB	4
Elation Platinum HFX	8
Martin Atomic 3000 DMX	2

DISCLAIMER

THIS DRAWING REPRESENTS VISUAL CONCEPTS AND CONSTRUCTION SUGGESTIONS ONLY. THE DESIGNER IS NOT QUALIFIED TO DETERMINE THE STRUCTURAL APPROPRIATENESS OF THIS DESIGN AND WILL NOT ASSUME RESPONSIBILITY FOR IMPROPER ENGINEERING, CONSTRUCTION, OR HANDLING. ALL MATERIALS, FINISHES, AND CONSTRUCTION MUST COMPLY WITH FIRE AND SAFETY CODES AS APPLICABLE.

No.	Date	By	Revision Notes
A	8/25/2021		Initial concept plot



Ayre Productions
4255 N Knox Ave
Chicago IL, 60641

Author: JACK WEIMER
jack@ayreproductions.com
614-580-4268

Project Title: **Prairie Fest 2021**

Sheet Title: **Lighting - Right Isometric**

Project Manager: Joey Wagner	Project ID: PF2021
Drawn By: Jack Weimer	Date: See Annotation
Reviewed By:	Sheet No. 5
Date: 9/1/2021	of 5
Client File Name: Prairie Fest.vwx	5

5-1 Lighting - Right Isometric
Scale: 3/4" = 1'-0"